



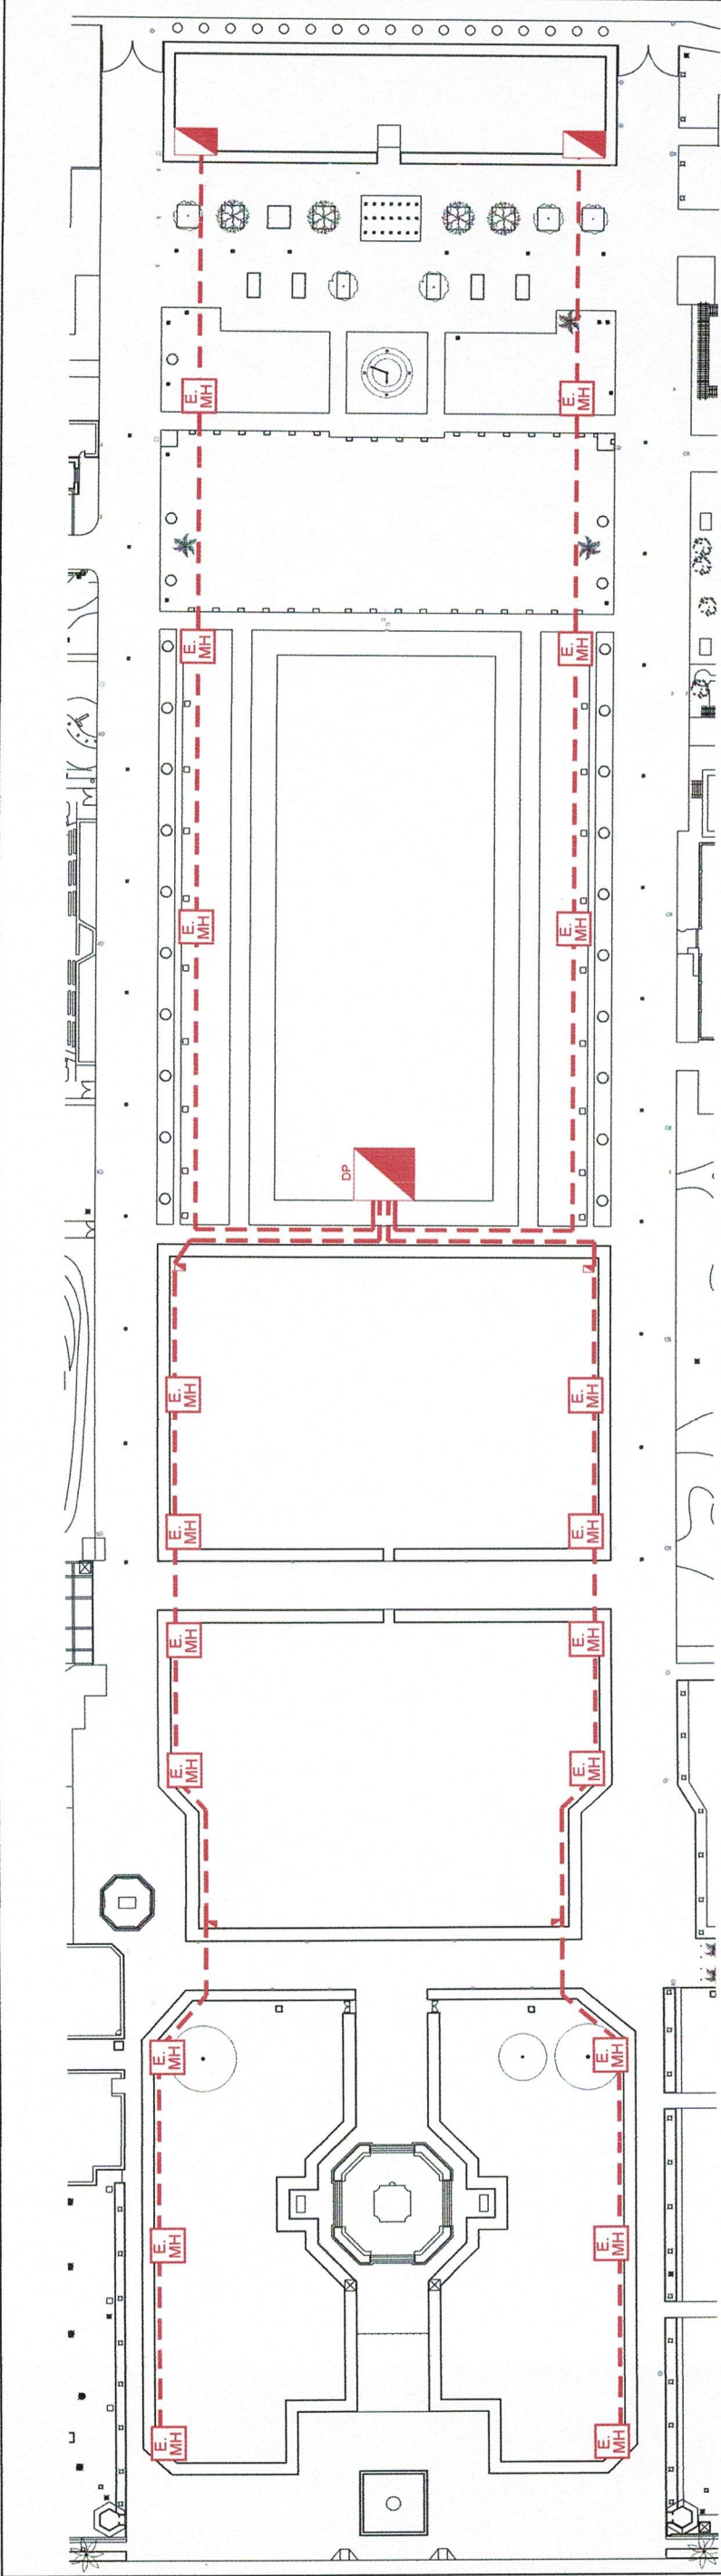


1 ELECTRICAL LINE PLAN
E-01 SCALE: 1:600

LEGENDS:


- E. MH ELECTRICAL MANHOLE
- RED ORANGE PVC CONDUIT

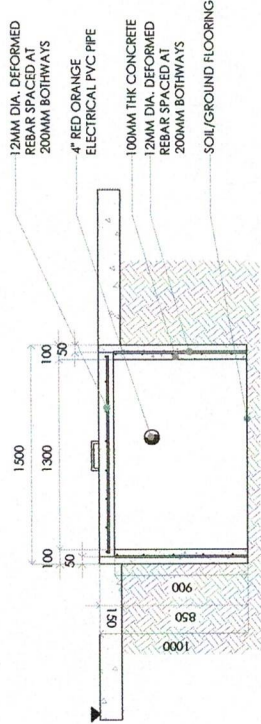


2 SECTION B-B
E-01 SCALE: 1:50

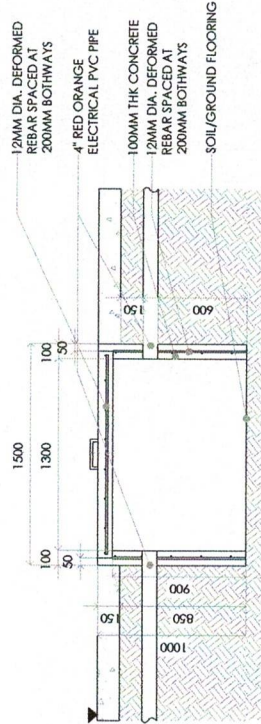


3 SECTION B-B
E-01 SCALE: 1:50

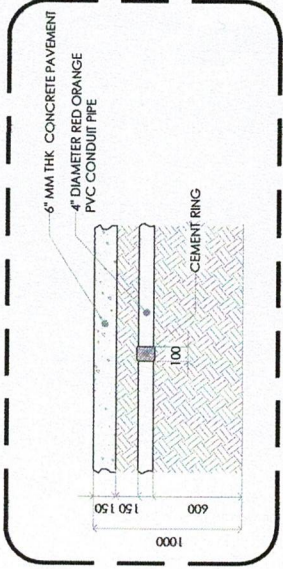


4 PIPE CONNECTION DETAILS
E-01 SCALE: 1:50

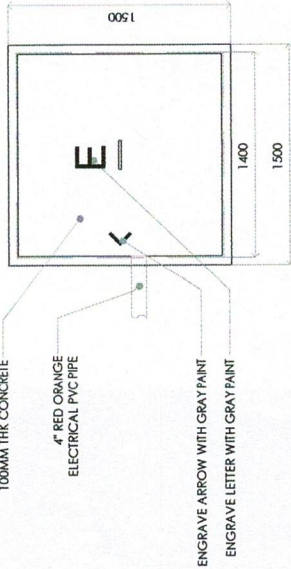


5 ELECTRICAL MANHOLE PLAN (TYPICAL)
E-01 SCALE: 1:50

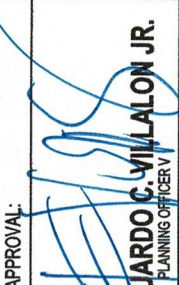 NATIONAL PARKS DEVELOPMENT COMMITTEE CENTRAL SECTION, RIZAL PARK, MANILA	PROJECT TITLE : IMPLEMENTATION OF RIZAL PARK COMPLEX COMPREHENSIVE TOURISM PLAN (IMPROVEMENT OF ROADS AND PATHS AT CENTRAL SECTION, RIZAL PARK) - PHASE II LOCATION: CENTRAL SECTION, RIZAL PARK ERMITA MANILA	PREPARED BY: AR. SARAH JANE A. GRANADA PROFESSIONAL IV	RECOMMENDING APPROVAL:  ENGR. EDUARDO C. VILLALON JR. PLANNING OFFICER V	APPROVED BY:  CECILLE A. LORENZANA-ROMERO EXECUTIVE DIRECTOR III	SHEET CONTENT ELECTRICAL LINE PLAN	PROJECT REF. NO. C-13 SHEET NO. E-01
		CHECKED BY: ENGR. MICHEL RANIEL M. REGALARIO PARK OPERATIONS SUPERVISOR II				

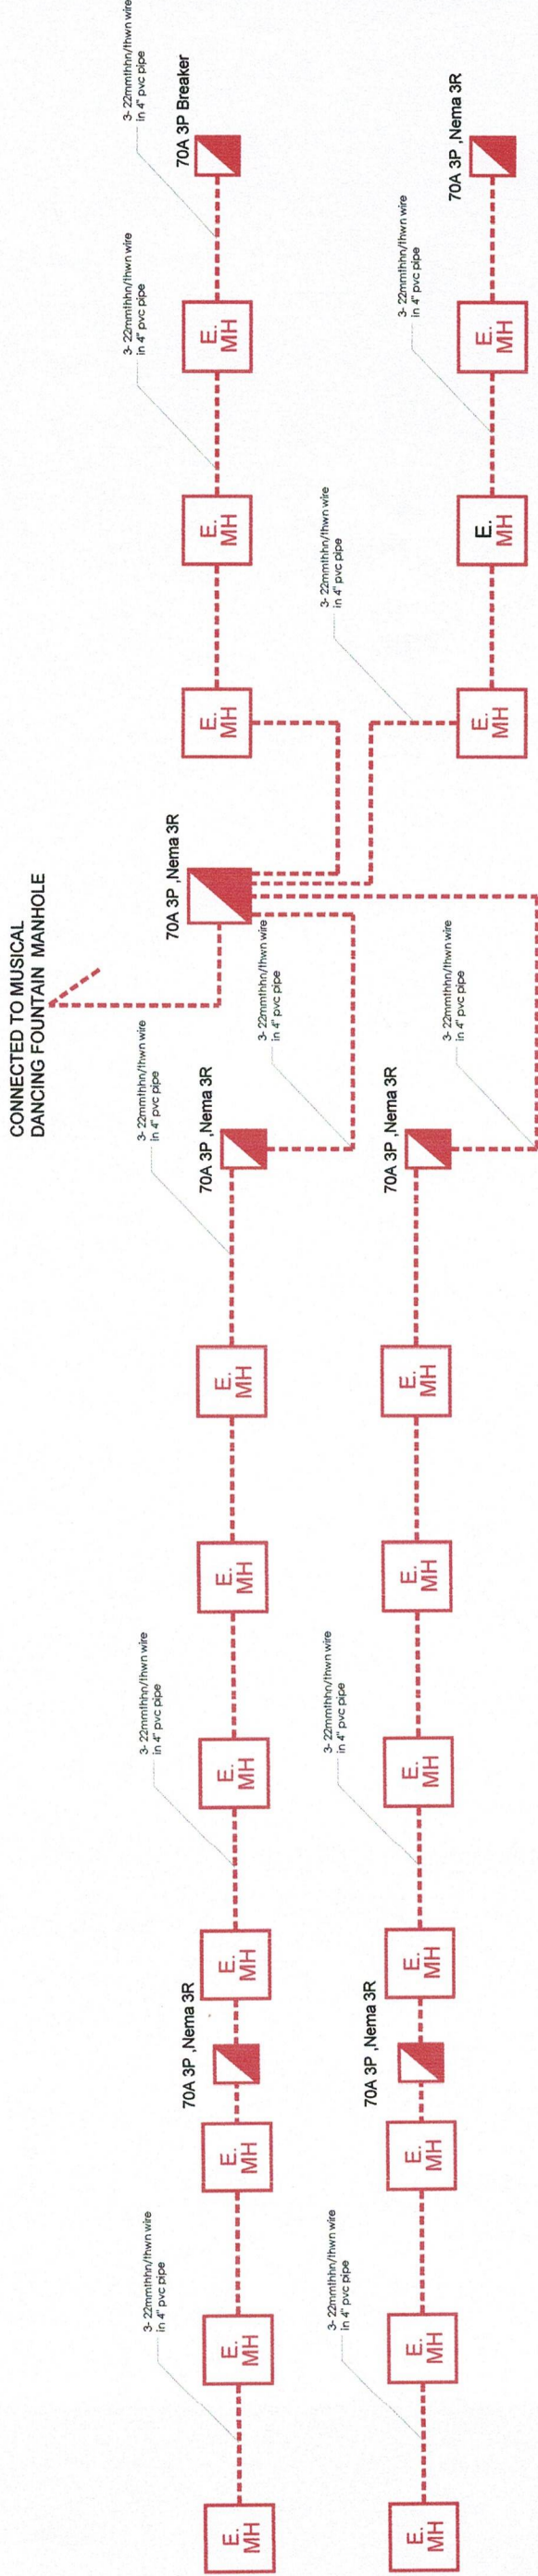

1 SINGLE LINE DIAGRAM
E-02 SCALE: NTS

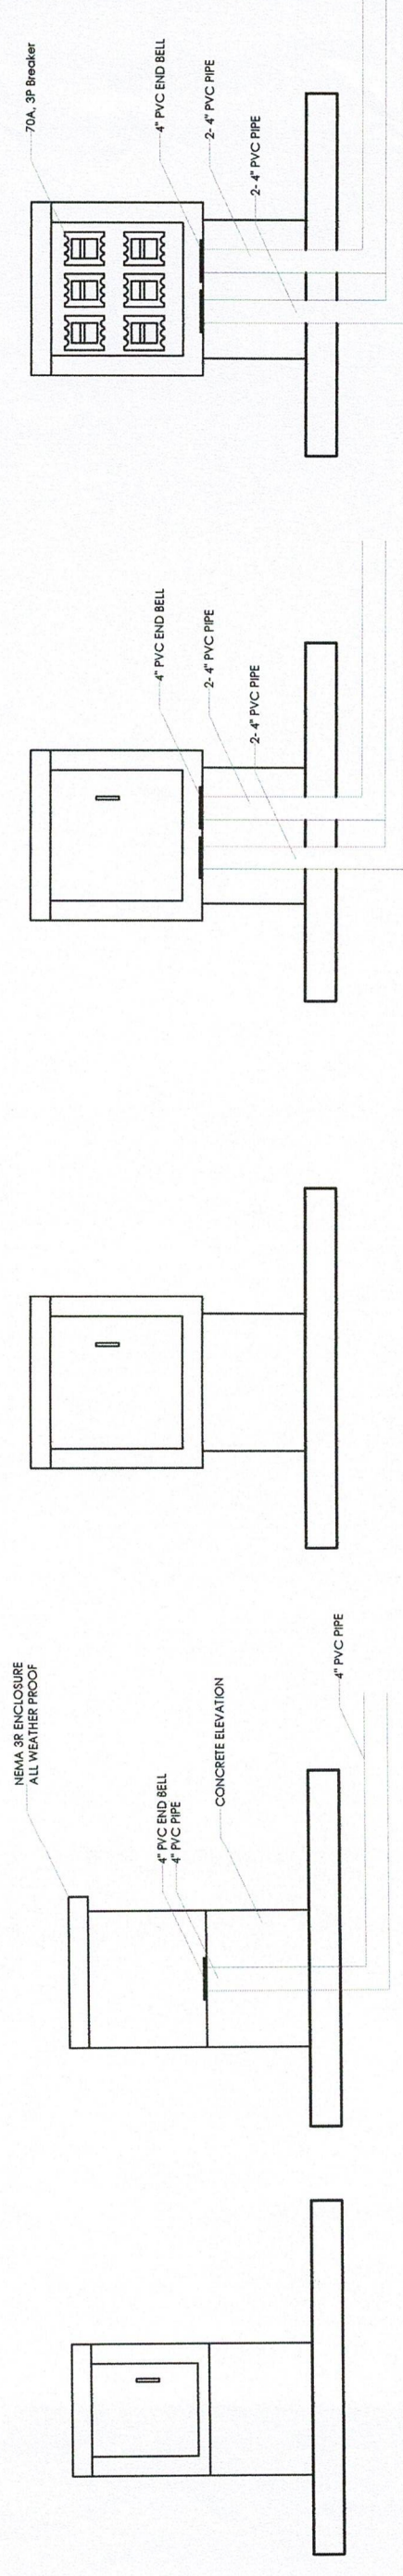

2 TYPICAL TAPPING POINT
E-02 SCALE: NTS

 NATIONAL PARKS DEVELOPMENT COMMITTEE CENTRAL SECTION, RIZAL PARK, MANILA	PROJECT TITLE: IMPLEMENTATION OF RIZAL PARK COMPLEX COMPREHENSIVE TOURISM PLAN (IMPROVEMENT OF ROADS AND PATHS AT CENTRAL SECTION, RIZAL PARK) - PHASE II LOCATION: CENTRAL SECTION, RIZAL PARK ERMITA MANILA		PREPARED BY: AR. SARAH JANE A. GRANADA DRAFTSMAN IV	RECOMMENDING APPROVAL: ENGR. EDUARDO C. VILLALON JR. PLANNING OFFICER V	APPROVED BY: CECILIE A. LORENZANA-ROMERO EXECUTIVE DIRECTOR III	SHEET CONTENT ELECTRICAL LINE PLAN	PROJECT REF. NO. C-13 SHEET NO. E-02
	CHECKED BY: ENGR. MICHELLE RAINEL M. REGALARIO PARK OPERATIONS SUPERINTENDENT II						