




LOCATION MAP
NOT TO SCALE




VICINITY MAP
NOT TO SCALE

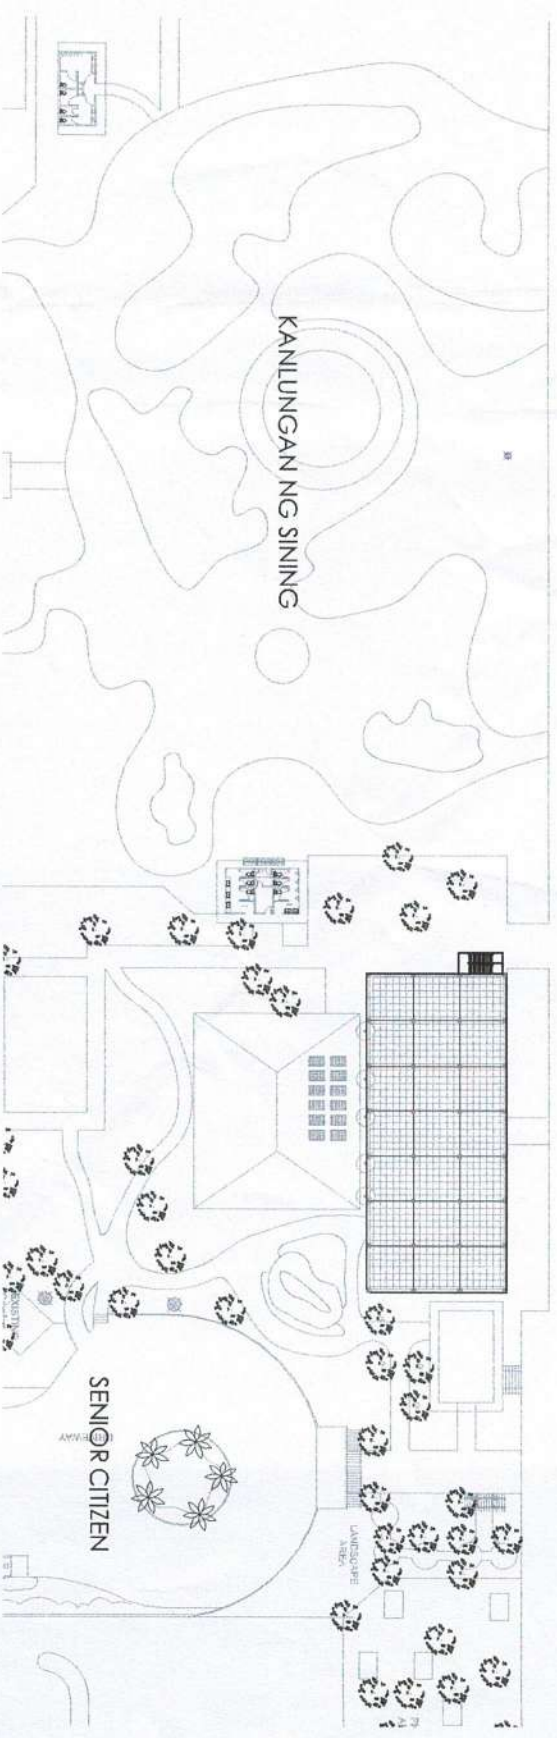

TAHANANG TEODORA ALONSO SITE PLAN
NOT TO SCALE




 NATIONAL PARKS DEVELOPMENT COMMITTEE CENTRAL SECTION, RIZAL PARK, MANILA	PROJECT TITLE:		PREPARED BY:	RECOMMENDING APPROVAL:	APPROVED BY:	SHEET CONTENT:	SHEET NO.:
	IMPROVEMENT OF TAHANANG TEODORA ALONSO- SECOND FLOOR		ENGR. LERZA S. CANALES PARK MAINTENANCE SUPERVISOR-4	ENGR. EDUARDO C. VILLALON JR. PMD CHIEF-PLANNING OFFICER IV	 CECILLE A. LORENZANA-ROMERO EXECUTIVE DIRECTOR III	- LOCATION MAP - TAHANANG TEODORA ALONSO SITE PLAN - TAHANANG TEODORA ALONSO	A-01
			CHECKED BY:				
			ENGR. MICHEL R. RAINEB M. REGALARIO PARK OPERATION SUPERINTENDENT				
	LOCATION: TAHANANG TEODORA ALONSO, CENTRAL SECTION, RIZAL PARK, ERMITA, MANILA						

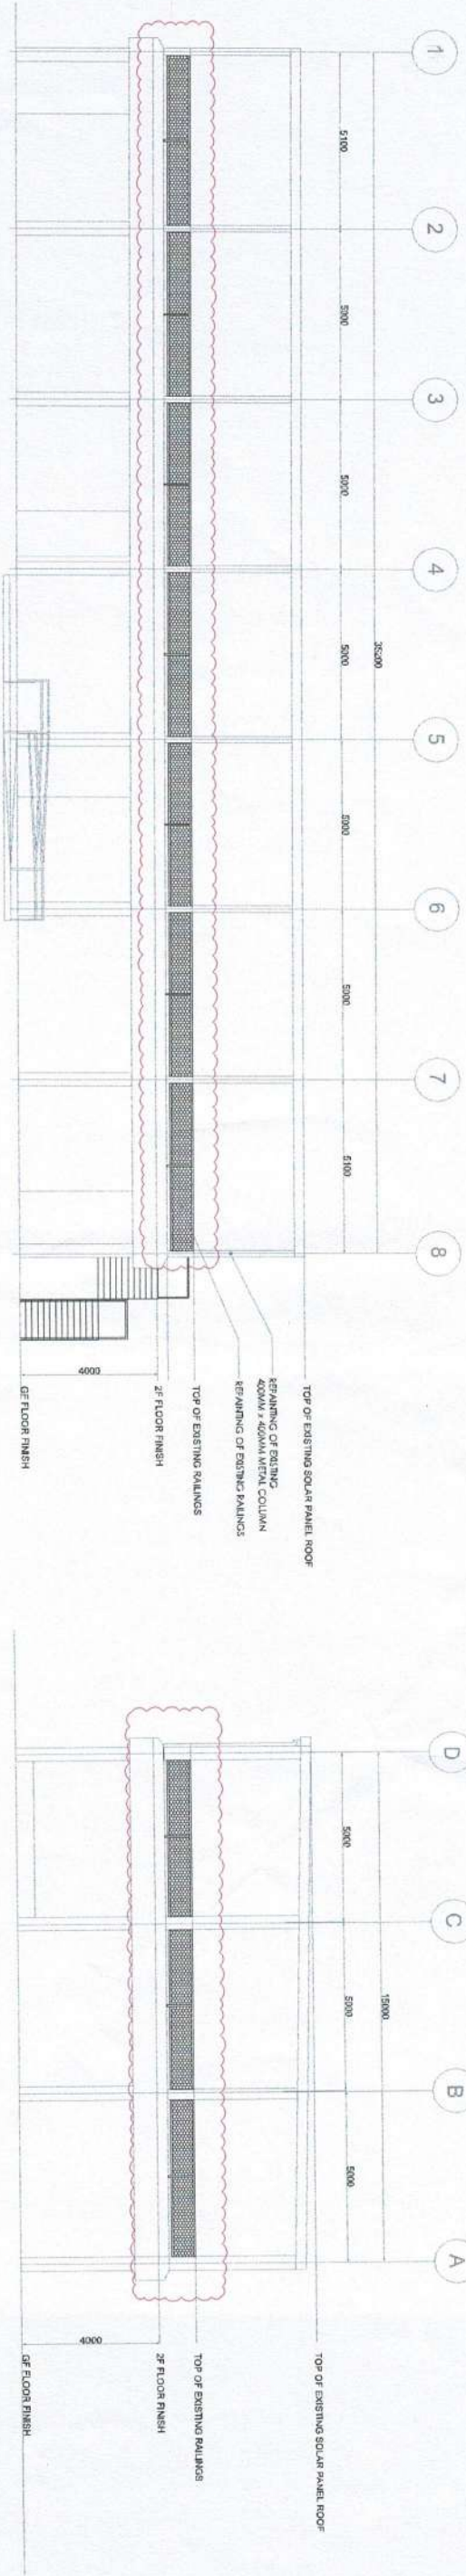

FRONT VIEW
SCALE 1:200

LEFT-SIDE VIEW
SCALE 1:200

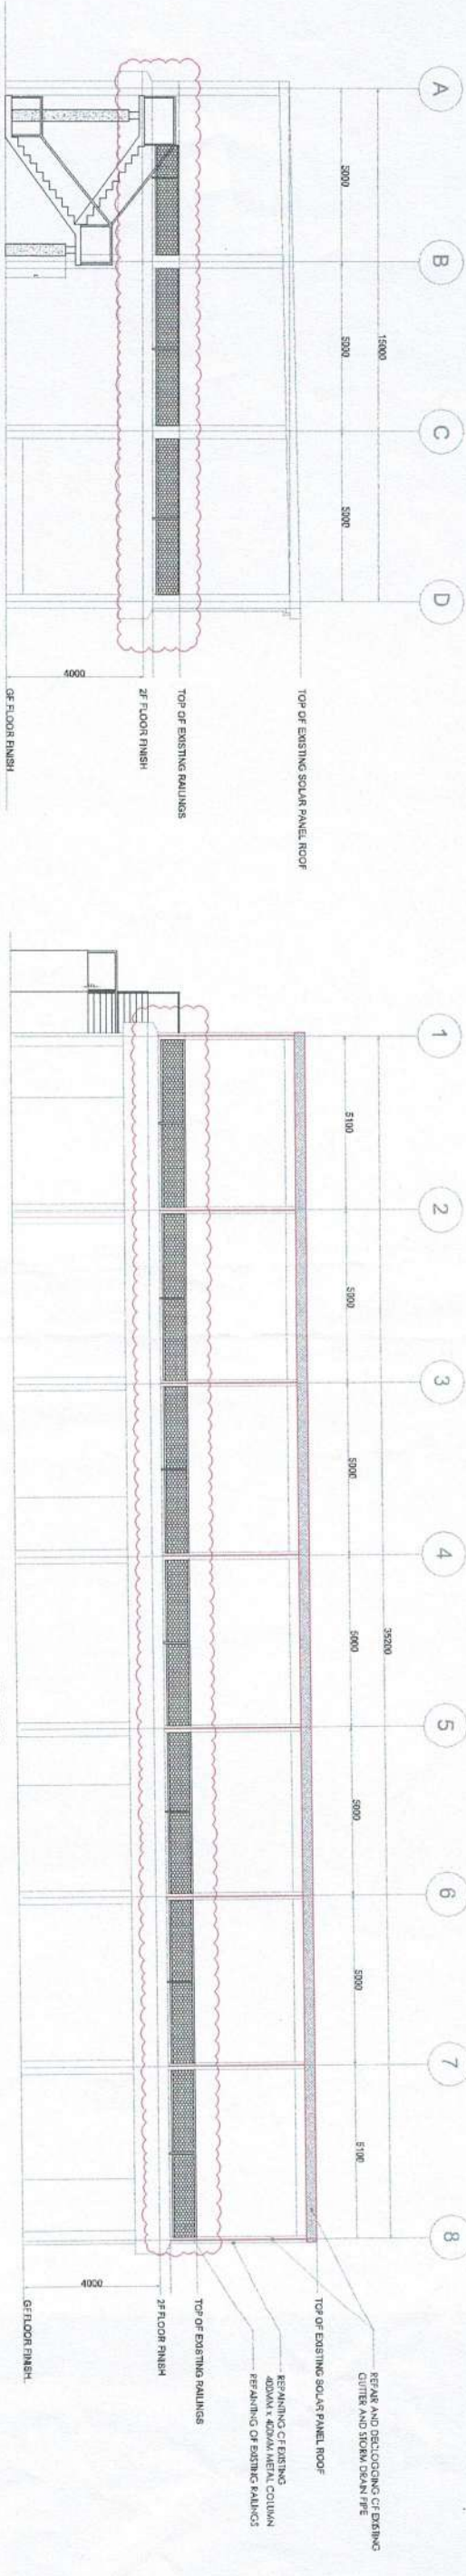



RIGHT-SIDE VIEW
SCALE 1:200

REAR VIEW
SCALE 1:200

LEGENDS:



- REPAINTING OF EXISTING RAILINGS
- EXISTING GUTTER


NATIONAL PARKS DEVELOPMENT COMMITTEE CENTRAL SECTION, RIZAL PARK, MANILA PROJECT TITLE: IMPROVEMENT OF TAHANANG TEODORA ALONSO- SECOND FLOOR		PREPARED BY: ENGR. LERIZA S. CANALES PARK MAINTENANCE SUPERVISOR-PLS CHECKED BY: ENGR. MICHEL RAINIER M. REGALARIO PARK OPERATION SUPERINTENDENT-PLS		RECOMMENDING APPROVAL: ENGR. EDUARDO C. VILLALON JR. PARK OPERATIONS OFFICER-IV APPROVED BY: CECILIE A. LORENZANA-ROMERO EXECUTIVE DIRECTOR III		SHEET CONTENT: FRONT VIEW LEFT-SIDE VIEW RIGHT-SIDE VIEW REAR VIEW LEGEND SHEET NO.: A-02	
--	--	--	--	---	--	---	--

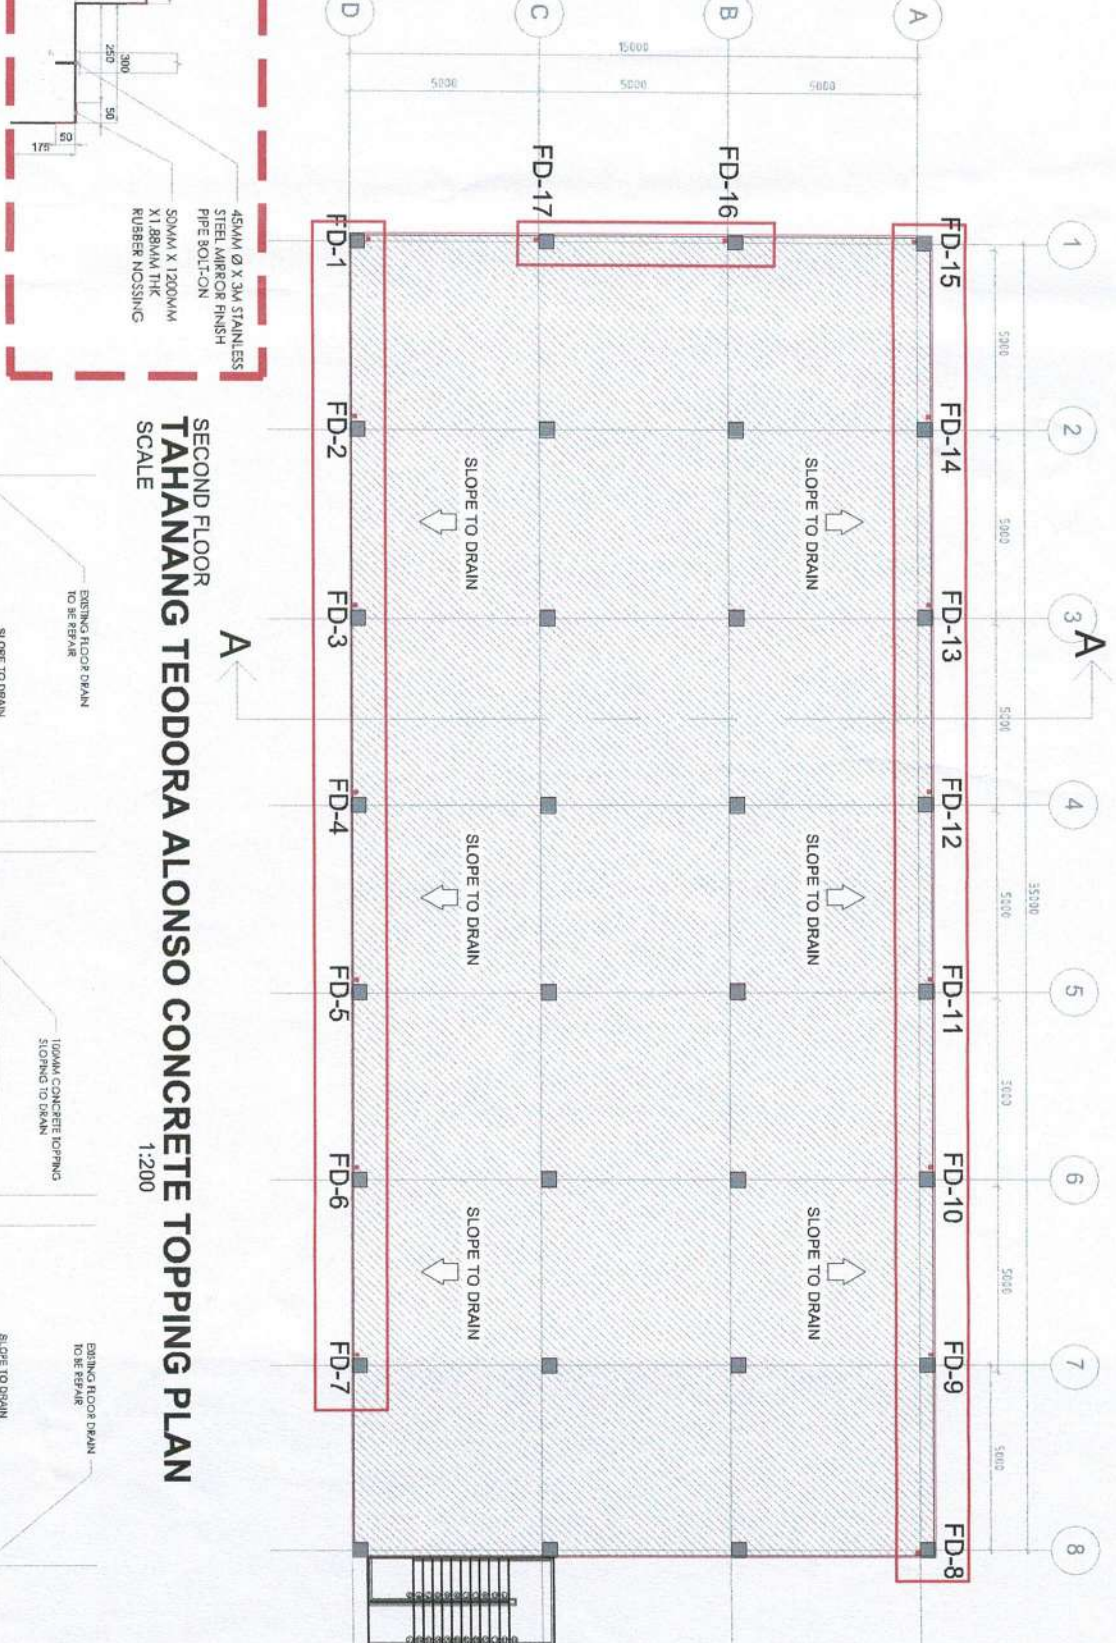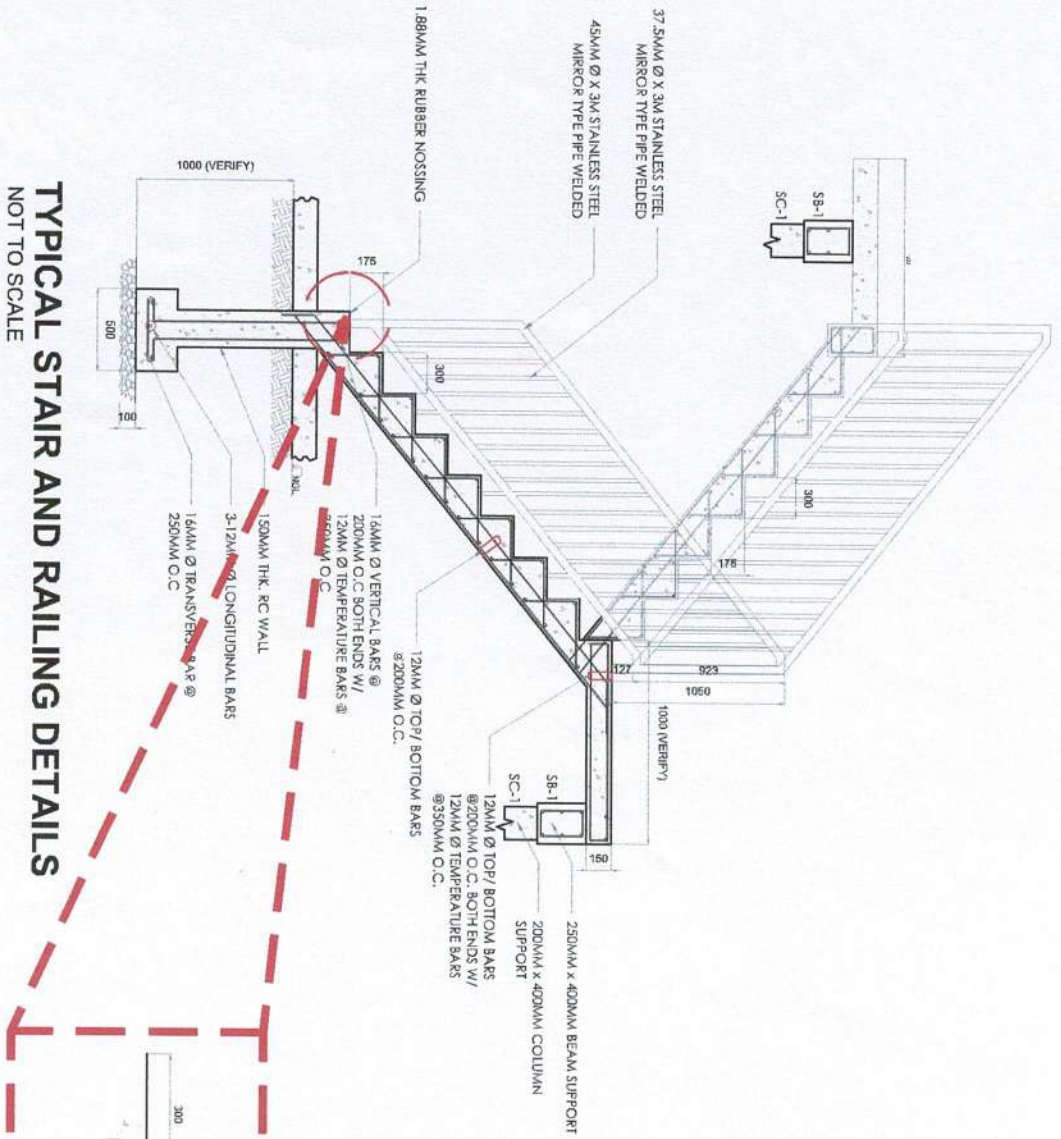


TYPICAL STAIR AND RAILING DETAILS
NOT TO SCALE

 SECTION A-A
SCALE 1:100

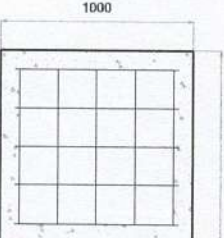
SCHEDULE OF FOOTING, COLUMN AND BEAM		
		
F-1	SC-1	SB-1
5- 16MM Ø VERTICAL BAR 5- 16MM Ø HORIZONTAL BAR	6- 16MM Ø VERTICAL BAR 10MM Ø TIES SPACED 2 @ 50MM O.C. 3 @ 100MM O.C. REST @ 150MM O.C.	5- 16MM Ø VERTICAL BAR 10MM Ø TIES SPACED 2 @ 50MM O.C. 3 @ 100MM O.C. REST @ 150MM O.C.

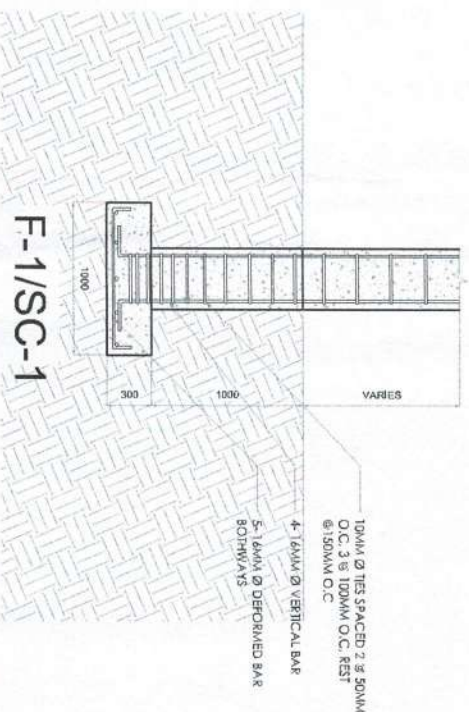


FOOTING AND COLUMN DETAILS
SCALE 1:50

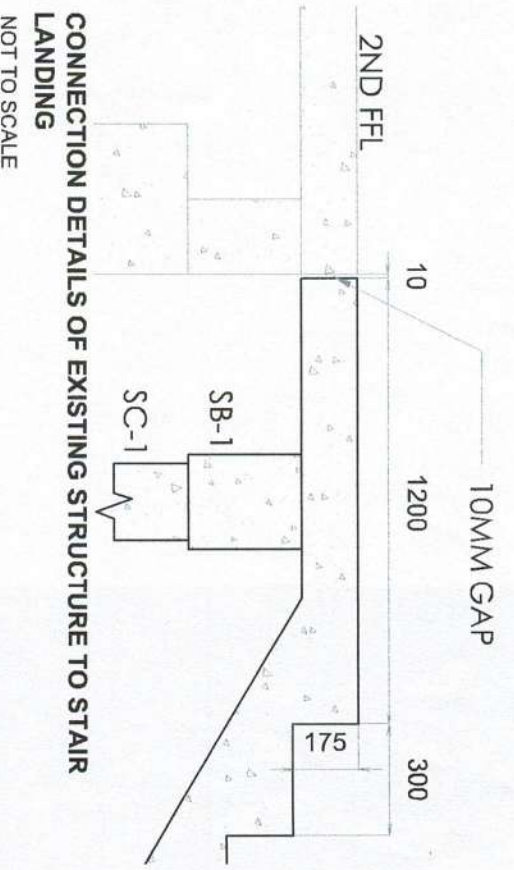


 NATIONAL PARKS DEVELOPMENT COMMITTEE CENTRAL SECTION, RIZAL PARK, MANILA	PROJECT TITLE:		PREPARED BY:		RECOMMENDING APPROVAL:		APPROVED BY:		SHEET CONTENT: - SECOND FLOOR PLAN - RAILING STAIRS AND - FOOTING AND COLUMN - DETAILS - SCHEDULE OF FOOTING AND COLUMN	SHEET NO.: A-03		
	IMPROVEMENT OF TAHANANG TEODORA ALONSO-SECOND FLOOR		ENGR. LERZA S. CANALES PARK MAINTENANCE SUPERVISOR		ENGR. EDUARDO C. VILLALON JR. PARK CHIEF PLANNING OFFICER V		CECILIE A. LORENZANA-ROMERO EXECUTIVE DIRECTOR III					
	LOCATION: TAHANANG TEODORA ALONSO, CENTRAL SECTION, RIZAL PARK, ERMITA, MANILA		CHECKED BY: ENGR. MICHEL RAINA M. REGALARIO PARK OPERATION SUPERINTENDENT		ROSALINA P. TENEPERE PARK OPERATION SUPERINTENDENT V							

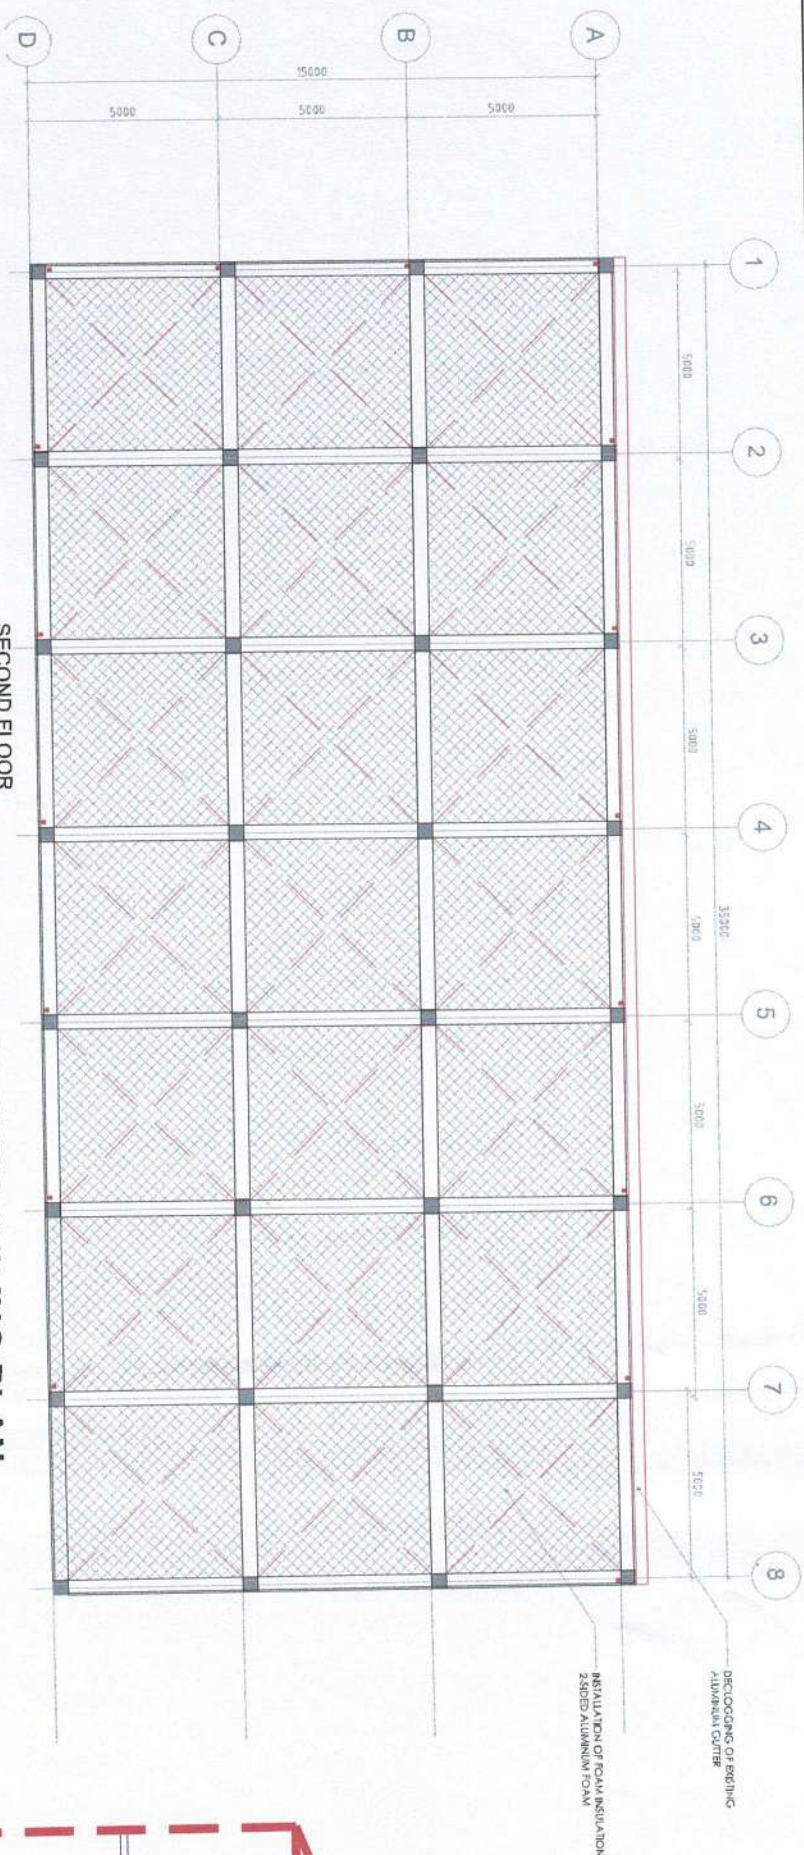


SECOND FLOOR
TAHANANG TEODORA ALONSO CEILING PLAN
SCALE 1:200

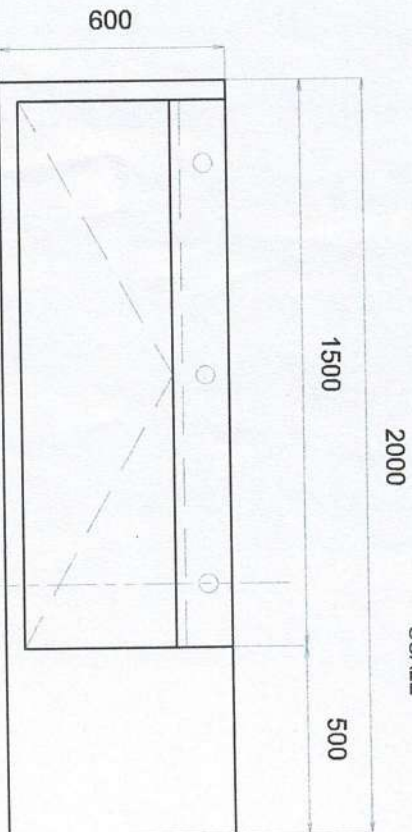


SECOND FLOOR-TAHANANG TEODORA ALONSO
CONCRETE RAMP SINK PLAN
SCALE 1:20

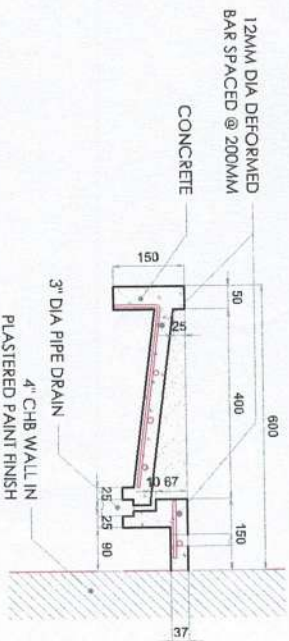


SECOND FLOOR-TAHANANG TEODORA ALONSO
TYPICAL CONCRETE RAMP SINK DETAILS
NOT TO SCALE

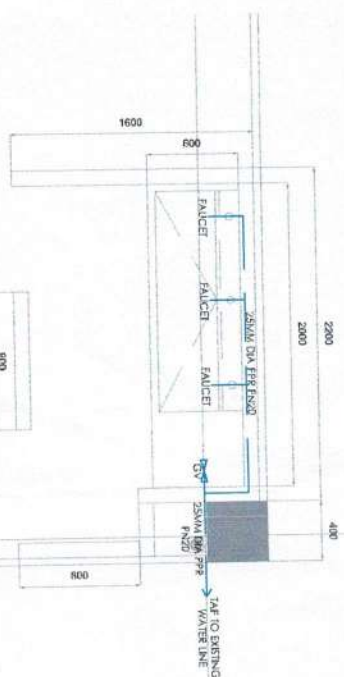

SECOND FLOOR-TAHANANG TEODORA ALONSO
WASH AREA WATER LINE
SCALE 1:50

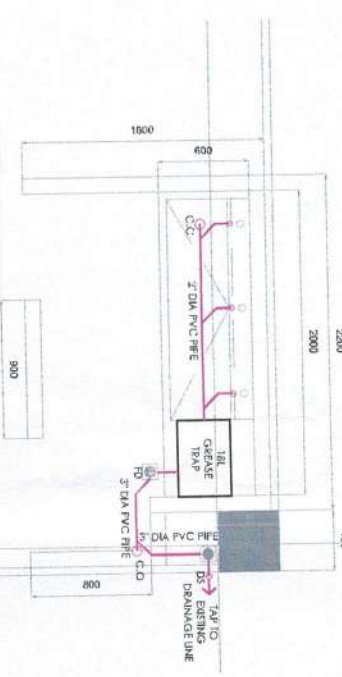


SECOND FLOOR-TAHANANG TEODORA ALONSO
WASH AREA SANITARY LINE
SCALE 1:50

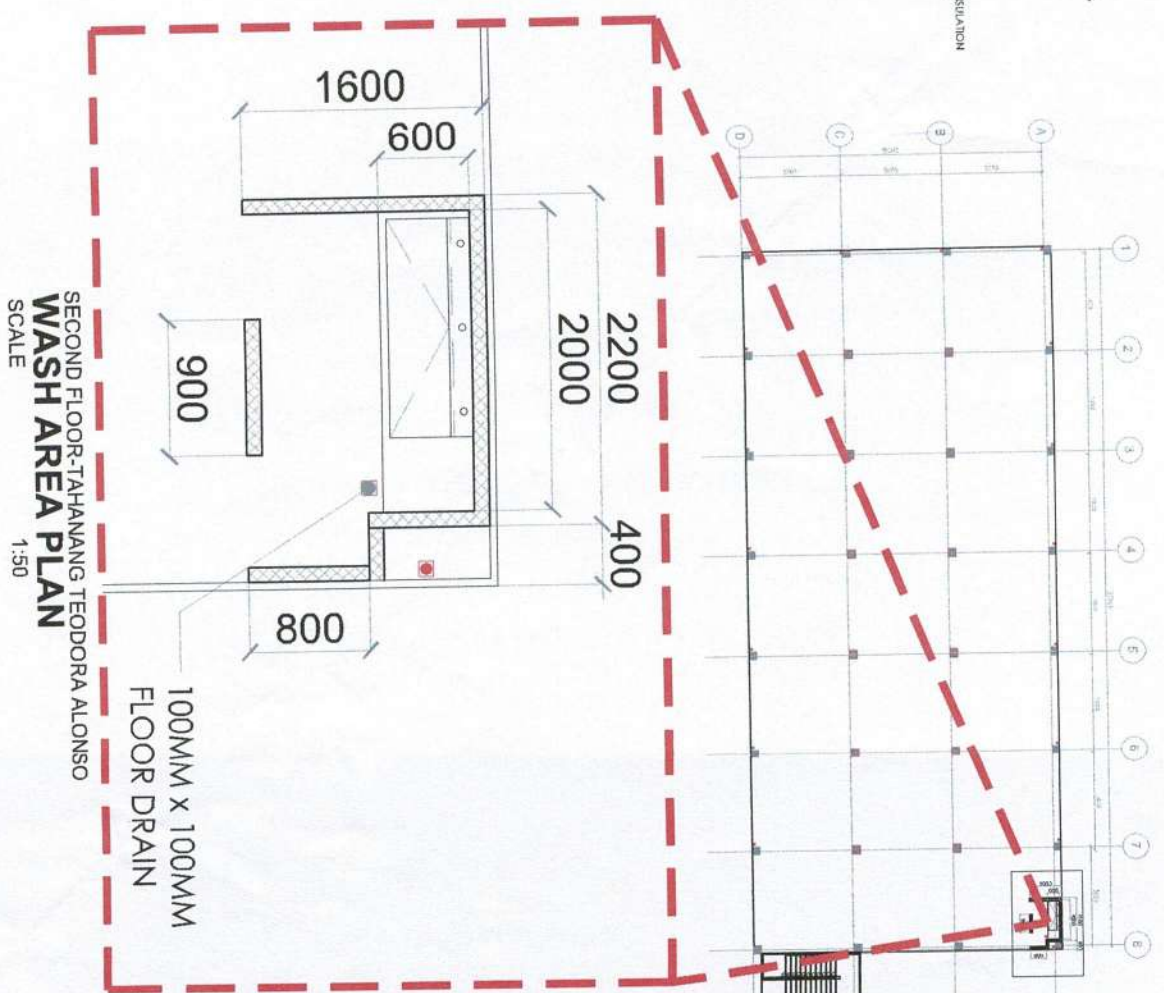


SECOND FLOOR-TAHANANG TEODORA ALONSO
WASH AREA- FRONT VIEW
SCALE 1:50

 NATIONAL PARKS DEVELOPMENT COMMITTEE CENTRAL SECTION, RIZAL PARK, MANILA	PROJECT TITLE: IMPROVEMENT OF TAHANANG TEODORA ALONSO- SECOND FLOOR		PREPARED BY: ENGR. LERIZA S. GANALES PARK MAINTENANCE SUPERINTENDENT	RECOMMENDING APPROVAL: ENGR. EDUARDO C. VILLALON JR. PARK PLANNING OFFICER IV	APPROVED BY: CECILIE A. LORENZANA-ROMERO EXECUTIVE DIRECTOR III	SHEET CONTENT: - WASH AREA PLAN - WASH AREA FRONT VIEW - WASH AREA WATER LINE - TYPICAL CONCRETE RAMP SINK DETAILS	SHEET NO.: P-01
	LOCATION: TAHANANG TEODORA ALONSO, CENTRAL SECTION, RIZAL PARK, BUNTA MARA		CHECKED BY: ENGR. MICHEL RAINIER M. REGALARIO PARK OPERATION SUPERINTENDENT	ROSALINA P. TENEPERE PARK OPERATION SUPERINTENDENT			

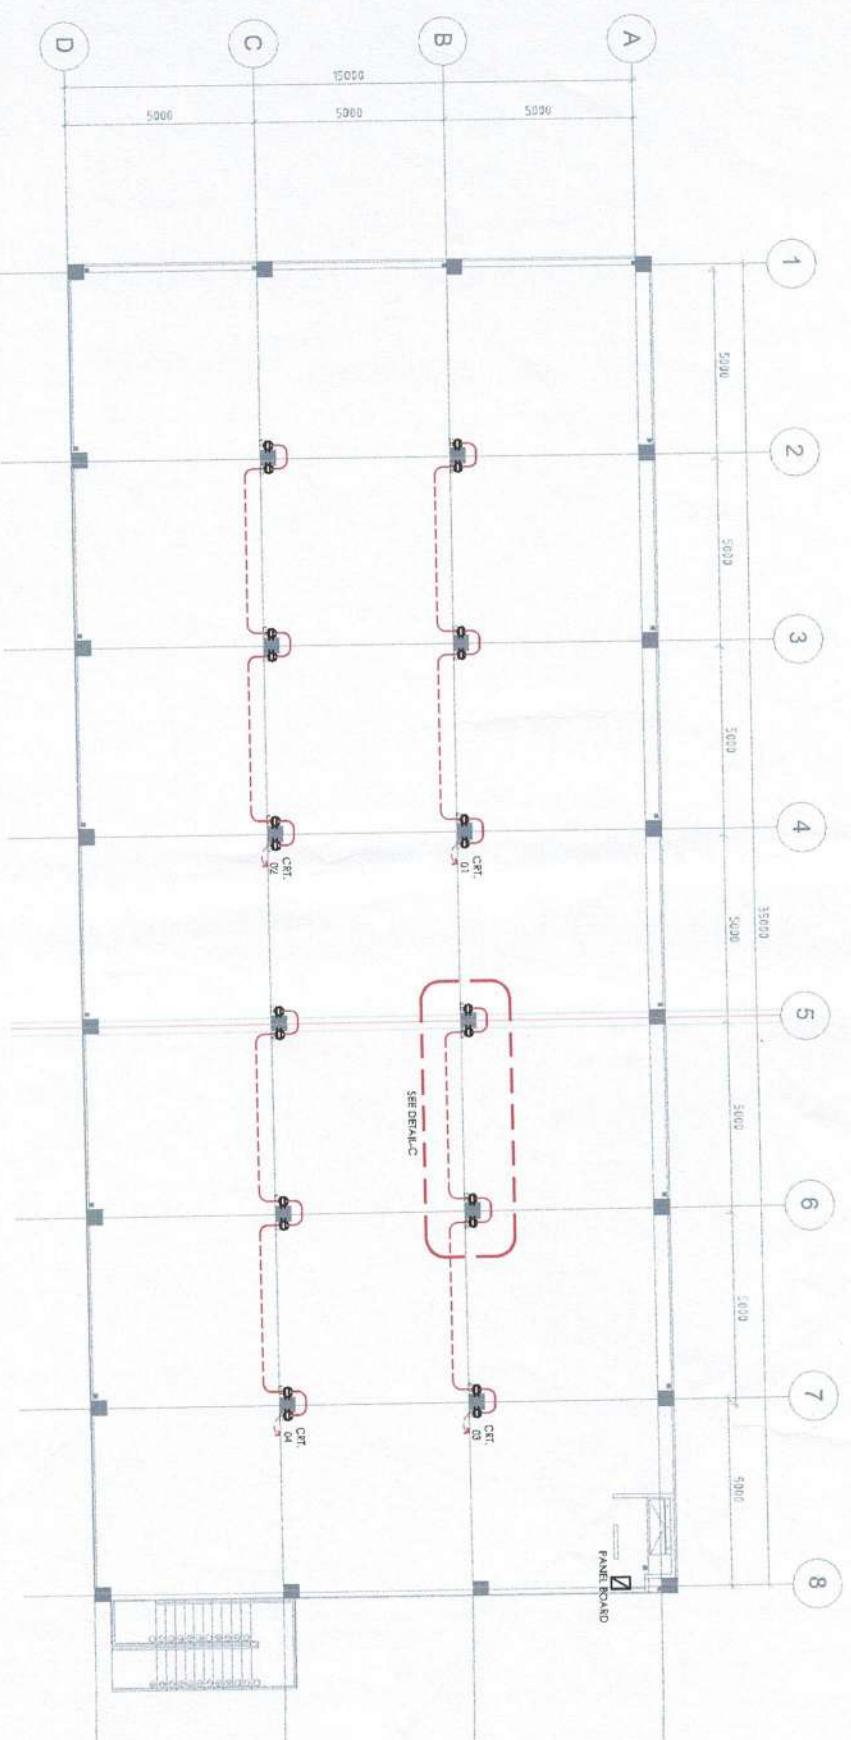


SECOND FLOOR
TAHANANG TEODORA ALONSO ELECTRICAL PLAN
SCALE 1:200

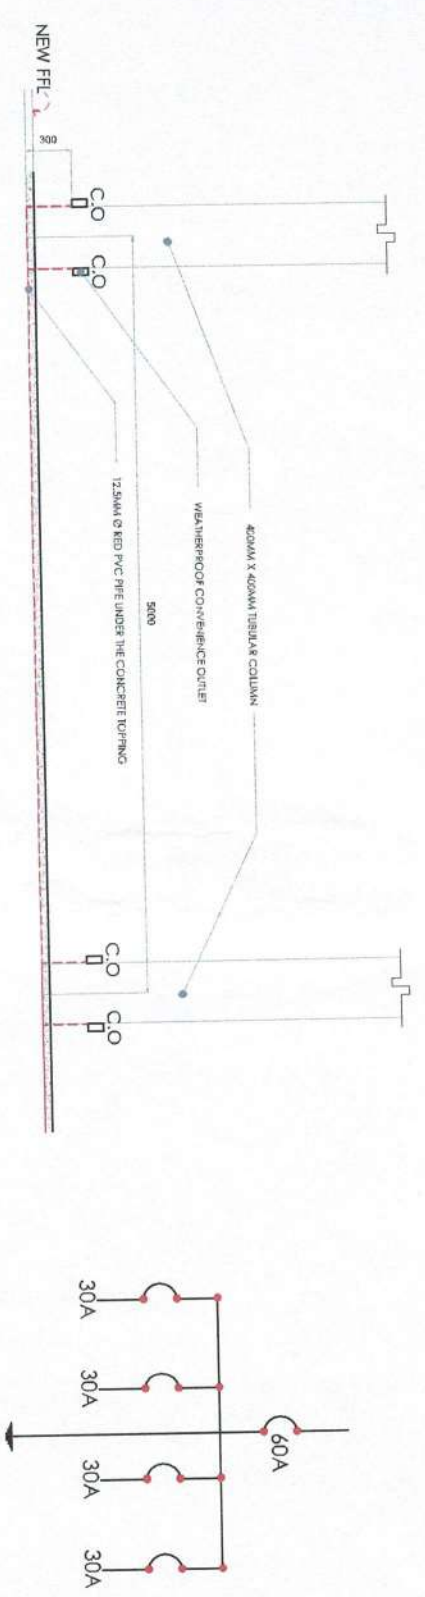


DETAIL-C
SCALE 1:50
SINGLE LINE DIAGRAM
NOT TO SCALE

	NATIONAL PARKS DEVELOPMENT COMMITTEE CENTRAL SECTION, RIZAL PARK, MANILA	PROJECT TITLE: IMPROVEMENT OF TAHANANG TEODORA ALONSO- SECOND FLOOR	PREPARED BY: ENGR. LERZA S. CAJALLES PARK MAINTENANCE SUPERVISOR	RECOMMENDING APPROVAL: ENGR. EDUARDO D. VILLALON JR. PARK CHIEF PLANNING OFFICER IV	APPROVED BY: CECILIE A. LORENZANA-ROMERO EXECUTIVE DIRECTOR III	SHEET CONTENT: - ELECTRICAL PLAN - DETAIL-C - SINGLE LINE - DIAGRAM	SHEET NO.: E-01
LOCATION: TAHANANG TEODORA ALONSO, CENTRAL SECTION, RIZAL PARK, BUNRAK MANILA	CHECKED BY: ENGR. MICHEL RAINES PARK OPERATION SUPERINTENDENT III						

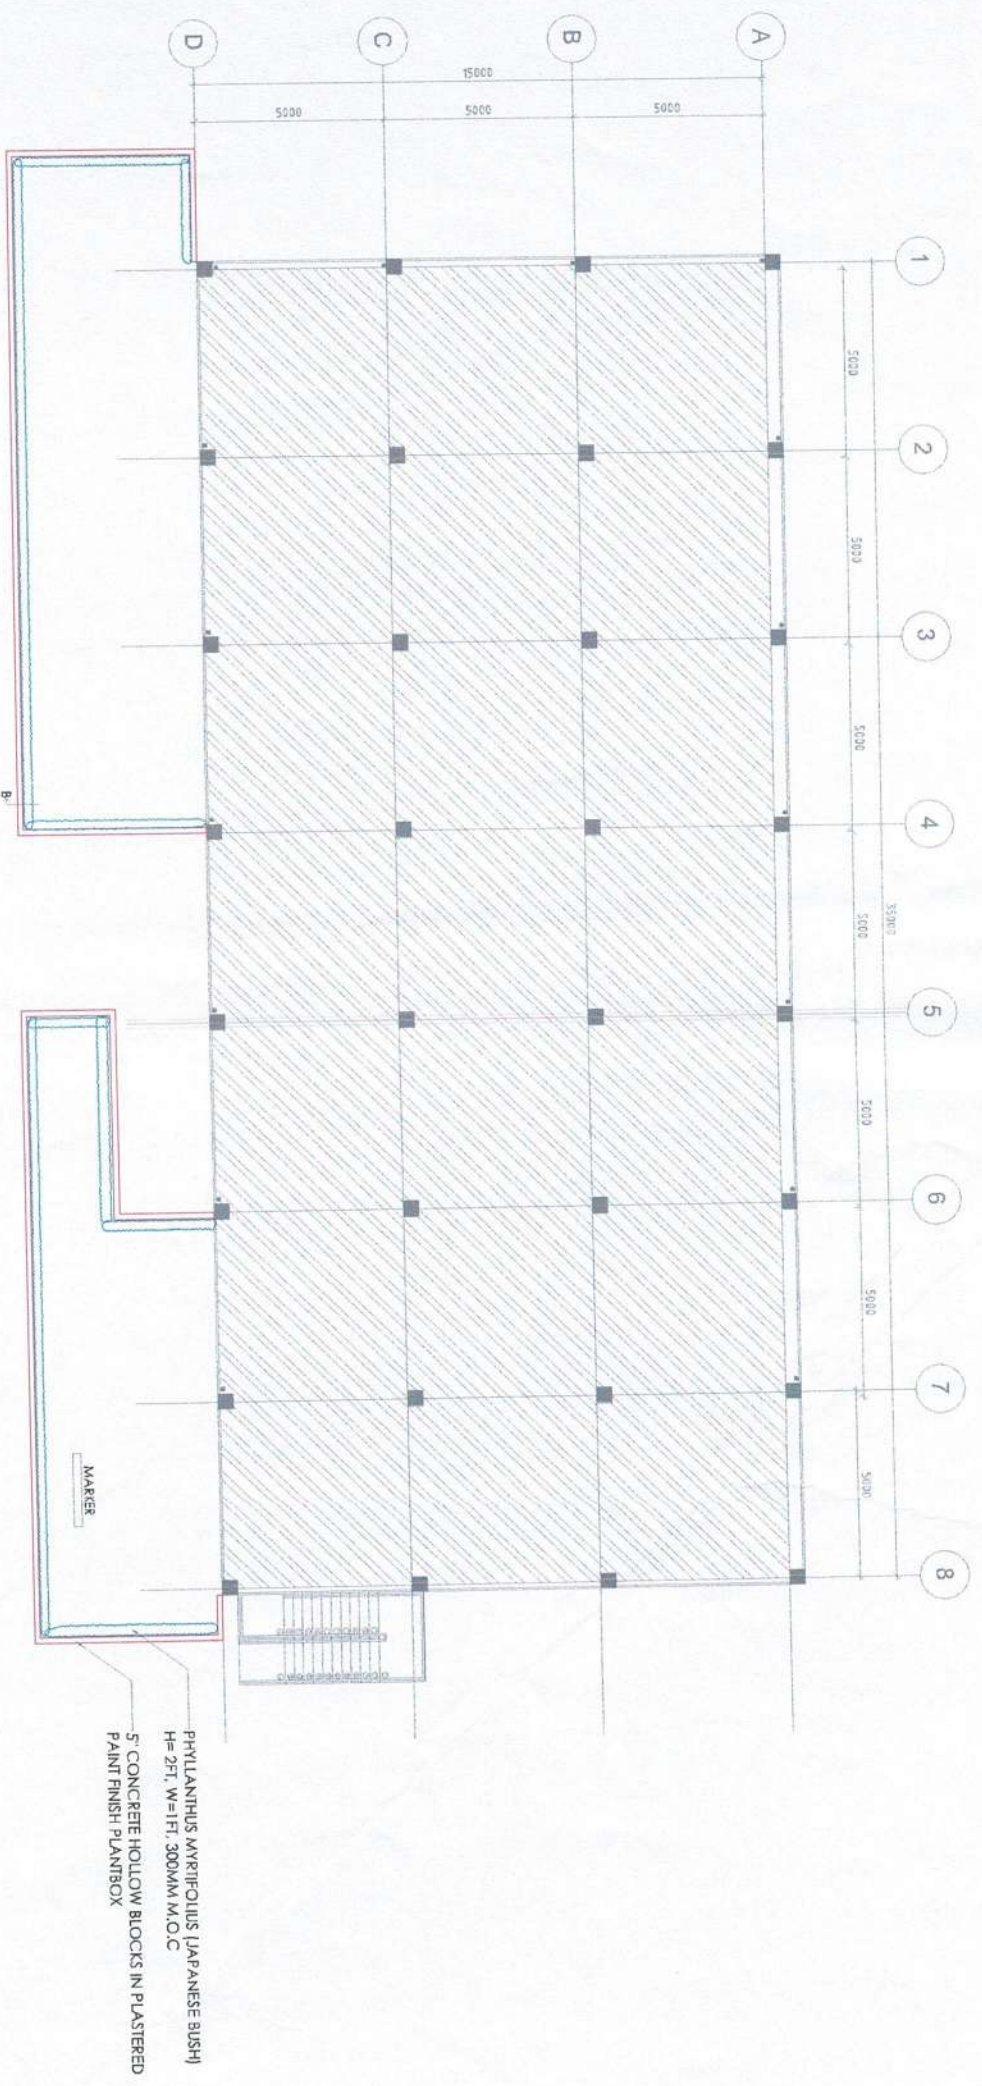

SECOND FLOOR
TAHANANG TEODORA ALONSO LANDSCAPE PLAN
SCALE 1:200

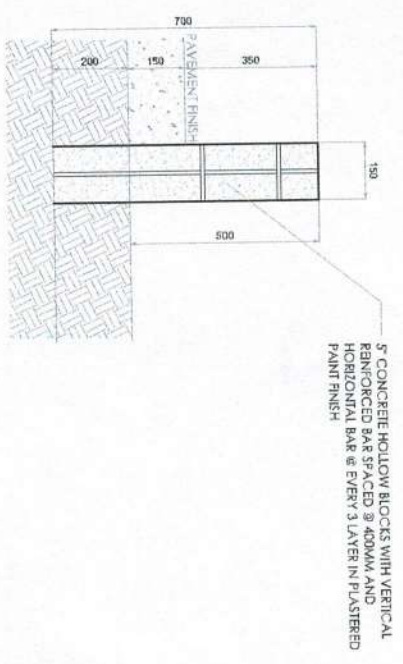

DETAIL-B
SCALE 1:50



PHYLLANTHUS MYRTIFOLIUS (JAPANESE BUSH)
NOT TO SCALE- IMAGE FOR REFERENCE

 NATIONAL PARKS DEVELOPMENT COMMITTEE CENTRAL SECTION, RIZAL PARK, MANILA		PROJECT TITLE: IMPROVEMENT OF TAHANANG TEODORA ALONSO- SECOND FLOOR		PREPARED BY: ENGR. LERZA S. VAIALES PARK MAINTENANCE SUPERVISOR		RECOMMENDING APPROVAL: ENGR. EDUARDO C. WILLALON JR. PMD CHIEF- PLANNING OFFICER V		APPROVED BY:  CECILLE A. LORENZANA-ROMERO EXECUTIVE DIRECTOR III		SHEET CONTENT: AS SHOWN		SHEET NO.: L-01	
LOCATION: TAHANANG TEODORA ALONSO CENTRAL SECTION, RIZAL PARK, EMVTA MANILA		CHECKED BY: ENGR. MICHEL RAINEL M. REGALARIO PARK OPERATION SUPERINTENDENT II-FMS		POD CHIEF: PARK OPERATION SUPERINTENDENT V									